



FRONT ELEVATION

| METER SIZE (mm) D | METER STAND PIPE SIZE (mm) | 6D (mm) |
|-------------------|----------------------------|---------|
| 20 | 20 | 120 |
| 25 | 25 | 150 |
| 40 | 40 | 240 |

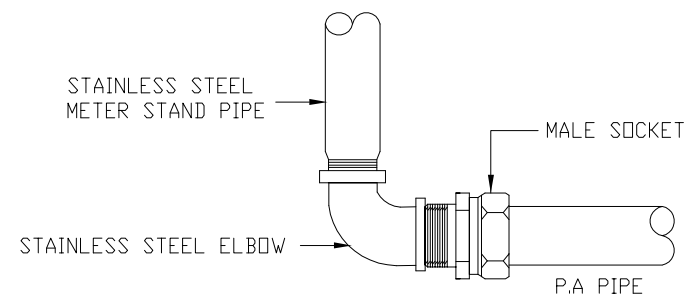

DETAIL 'A'
POLY ALUMINIUM COMMUNICATION PIPE

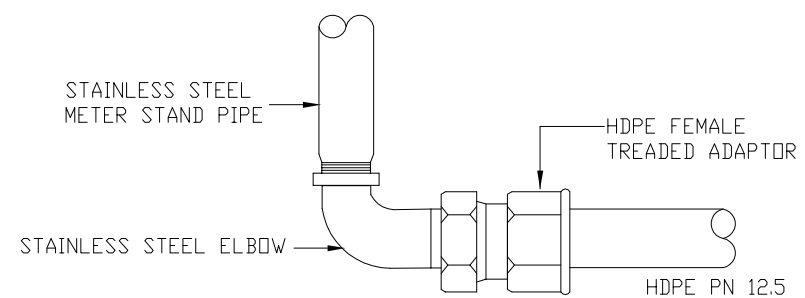

DETAIL 'A'
HDPE PN 12.5 COMMUNICATION PIPE

NOTE:

SPECIFICATIONS

1. ALL STAINLESS STEEL PIPES SHALL BE GRADE 304 COMPLYING WITH ASTM A312 (SCHEDULE 40S) OR BS 4127.
2. ALL FITTINGS SHALL BE OF STAINLESS STEEL CONFORMING TO ASTM A351 OR BRASS TREADED FITTINGS CONFORMING TO BS 443 & 1256.
3. BRASS LOCKABLE BALL VALVES (FULL BORE TYPE) SHALL COMPLY WITH BS 6675:1986 OR BS 1552:1995
4. BRASS GATE VALVE SHALL CONFORM TO BS 5154 AND SHALL BE OF THE FULL BORE TYPE.

DETAILS NOTE:

- 1 COMMUNICATION PIPE POLY ALUMINIUM / HDPE PN 12.5
- 2 STAINLESS STEEL ELBOW (INTERNALLY TREADED)
- 3 STAINLESS STEEL PIPE(304)
- 4 STAINLESS STEEL STRAIGHT / REDUCER ELBOW (MALE AND FEMALE TREAD)
- 5 CHECK VALVE
- 6 STAINLESS STEEL BUSH
- 7 BRASS UNION/COUPLING
- 8 WATER METER
- 9 STAINLESS STEEL SHORT PIECE
- 10 STAINLESS STEEL ELBOW (INTERNALLY TREADED)
- 11 STAINLESS STEEL SOCKET
- 12 SERVICE PIPE
- 13 STAINLESS STEEL NIPPLE

| REV. | REVISED BY | DESCRIPTION | DATE |
|------|------------|-------------|----------|
| 01 | NORAZLIN | CHANGE LOGO | JAN 2018 |
| | | | |
| | | | |
| | | | |
| | | | |
| | | | |
| | | | |
| | | | |
| | | | |

Ranhill SAJ
SAJ Ranhill Sdn. Bhd. (476718-H)
 Jalan Garuda, Larkin, P.O Box 262,
 80350 Johor Bahru, Johor, Malaysia
 T_+607-224 4040 F_+607-224 0033
 1800-88-7474 sms 019-772 7474 www.sajranhill.com.my customer.care@saj.com.my

PROJECT:

DRAWING TITLE:
 TYPICAL DOMESTIC SINGLE METER INSTALLATION
 (Meter Size 20mm , 25mm & 40mm)

DRAWN BY : MYR DESIGNED : W.C
 CHECKED : MFB APPROVED : T.C
 SCALE : NOT TO SCALE DATE : JAN 2018

DRAWING NO :
 SAJ/STD/MP/02 (01)